



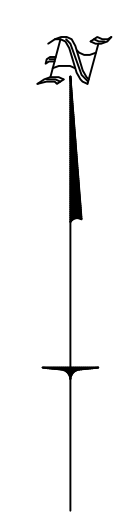


1 2 3 4 5

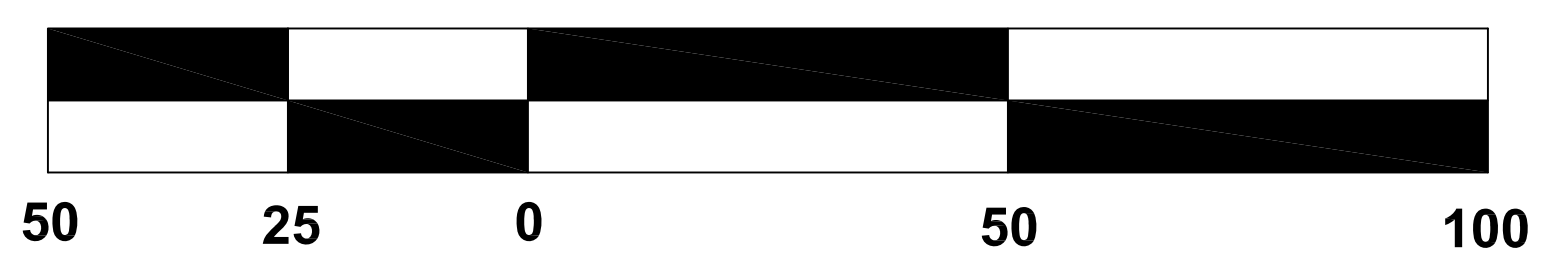


D  
C  
B  
A

D  
C  
B  
A

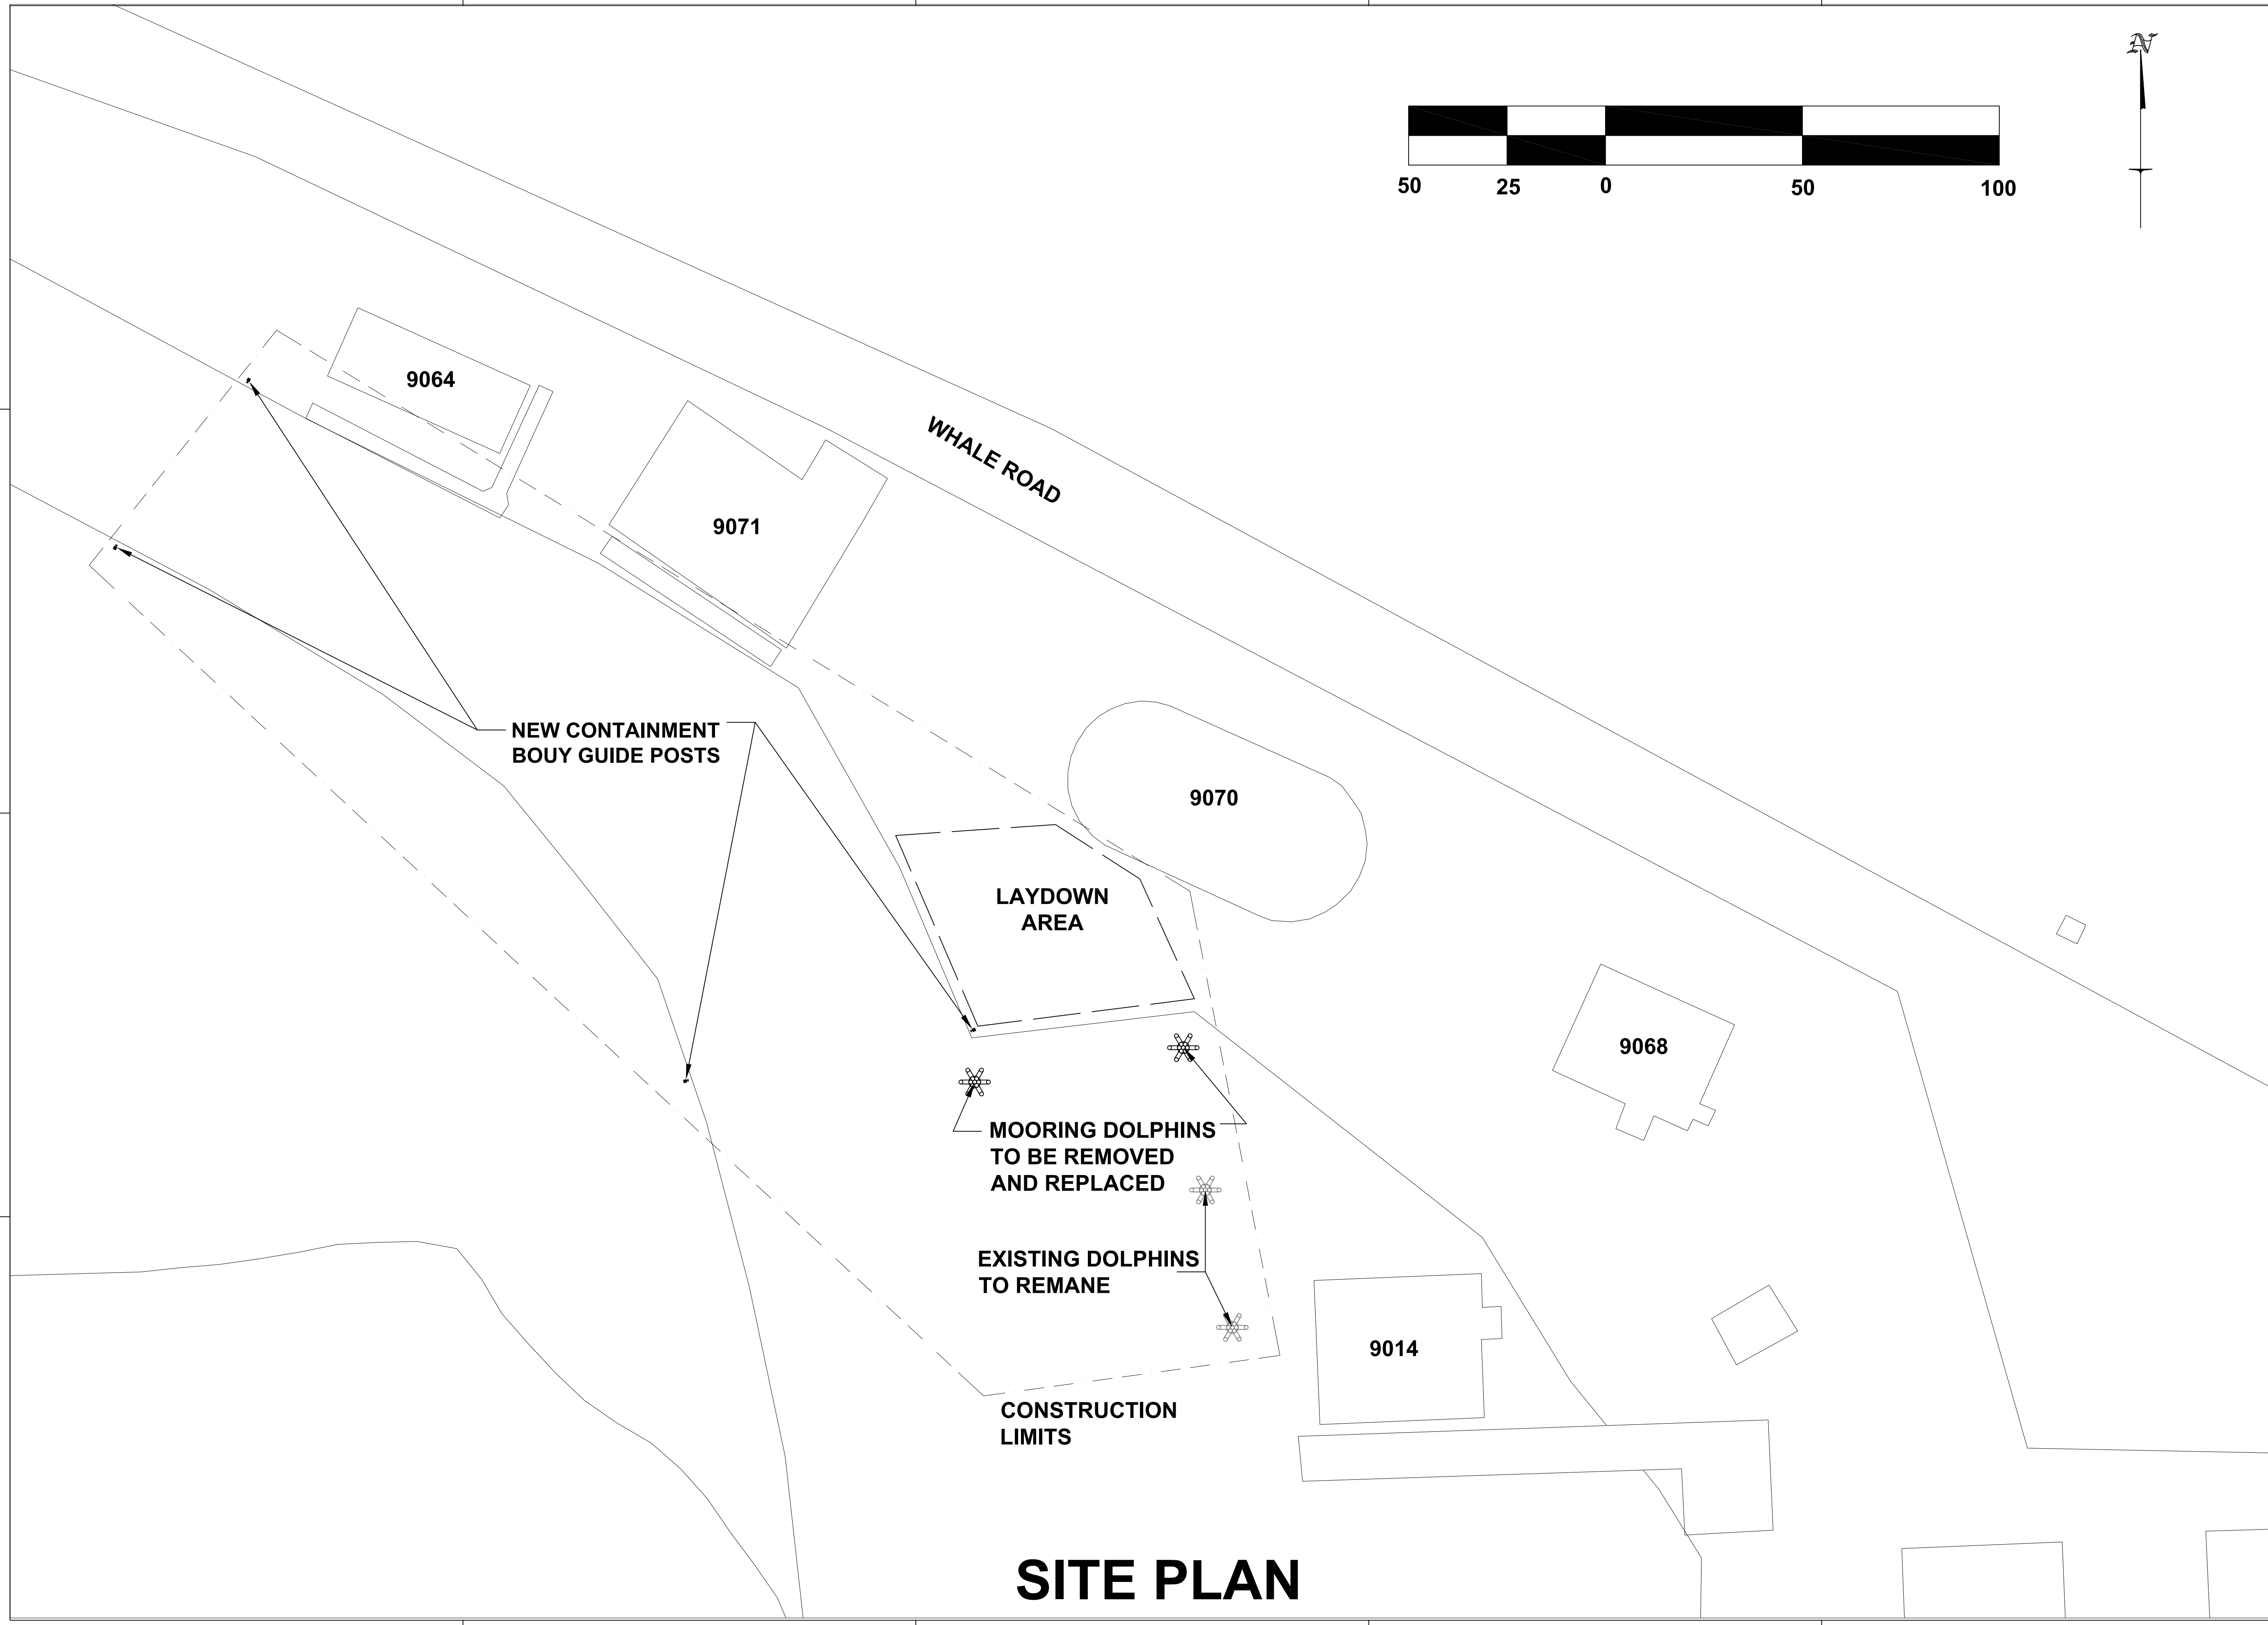

# SITE PLAN

1 2 3 4 5

SYMBOL	DESCRIPTION	DATE	APPR
DESIGNED & ENGINEERED BY: FACILITIES ENGINEERING FED			
 <small>U.S. MARINE CORPS</small> <small>U.S. DEPARTMENT OF THE NAVY</small>			
LET'S USE THIS SPACE FOR YOUR ADDRESS INFO			
SEAL			
APPROVED			
ACTIVITY - SATISFACTORY TO			
DATE APPROVED			
FOR EFD FOR COMMANDER NAVFAC			
DATE			
AE	EFD		
DESIGN	BMS		
DRAWN	BMS		
REVIEW	PGF		
QC	PGF		
CHIEF ARCH/ENGR.			
PROJECT MANAGER			
FIRE PROTECTION			
BRANCH MANAGER			
DESIGN DIRECTOR			
<small>DEPARTMENT OF THE NAVY</small> <small>NAVAL FACILITIES ENGINEERING COMMAND</small> <b>MARINE CORPS AIR STATION, CHERRY POINT, N.C.</b> <b>REPLACE MOORING DOLPHINS</b> <b>BT-11 FUEL DOCKS</b> <b>SITE PLAN</b>			
CODE ID. NO. 80091 SIZE D			
SCALE: AS SHOWN			
FED. NO.			
STA. PROJ. NO. 5784685			
SPEC. NO.			
CONSTR. CONTR. NO.			
NAVFAC DRAWING NO. 12587819			
SHEET 2 OF 3			
C-01			
<small>DRAWING REVISION AUGUST 2002</small>			

